

Front Elevation



Left Elevation

**GP Home Designs**

2664 248th Street  
Oskaloosa  
Iowa  
52577

PHONE: (641) 660-7256  
FAX:  
MOBILE:  
greg@GPhomedesigns



SECTION LETTER  
A  
PAGE NUMBERS  
1/1


PHONE: [REDACTED]  
FAX: [REDACTED]  
MOBILE: [REDACTED]

PAGE: 1/6  
Elevations

DRAWN BY: Greg Patton  
SCALE: As Noted  
DATE: Thursday, April 14, 2022



Right Elevation

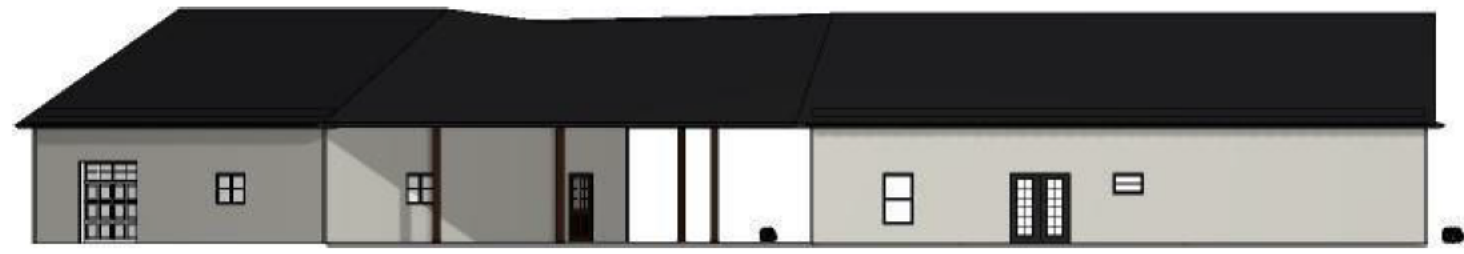

Back Elevation

SECTION LETTER  
**A**  
 PAGE NUMBERS  
**111**


PAGE: **2/6**  
 Elevation 2

PHONE: [REDACTED]  
 FAX:  
 MOBILE:

DRAWN BY: Greg Patton  
 SCALE: As Noted  
 DATE: Thursday, April 14, 2022

**GP Home Designs**  
 2664 248th Street  
 Oskaloosa  
 Iowa  
 52577  
 PHONE: (641) 660-7256  
 greg@GPhomedesigns



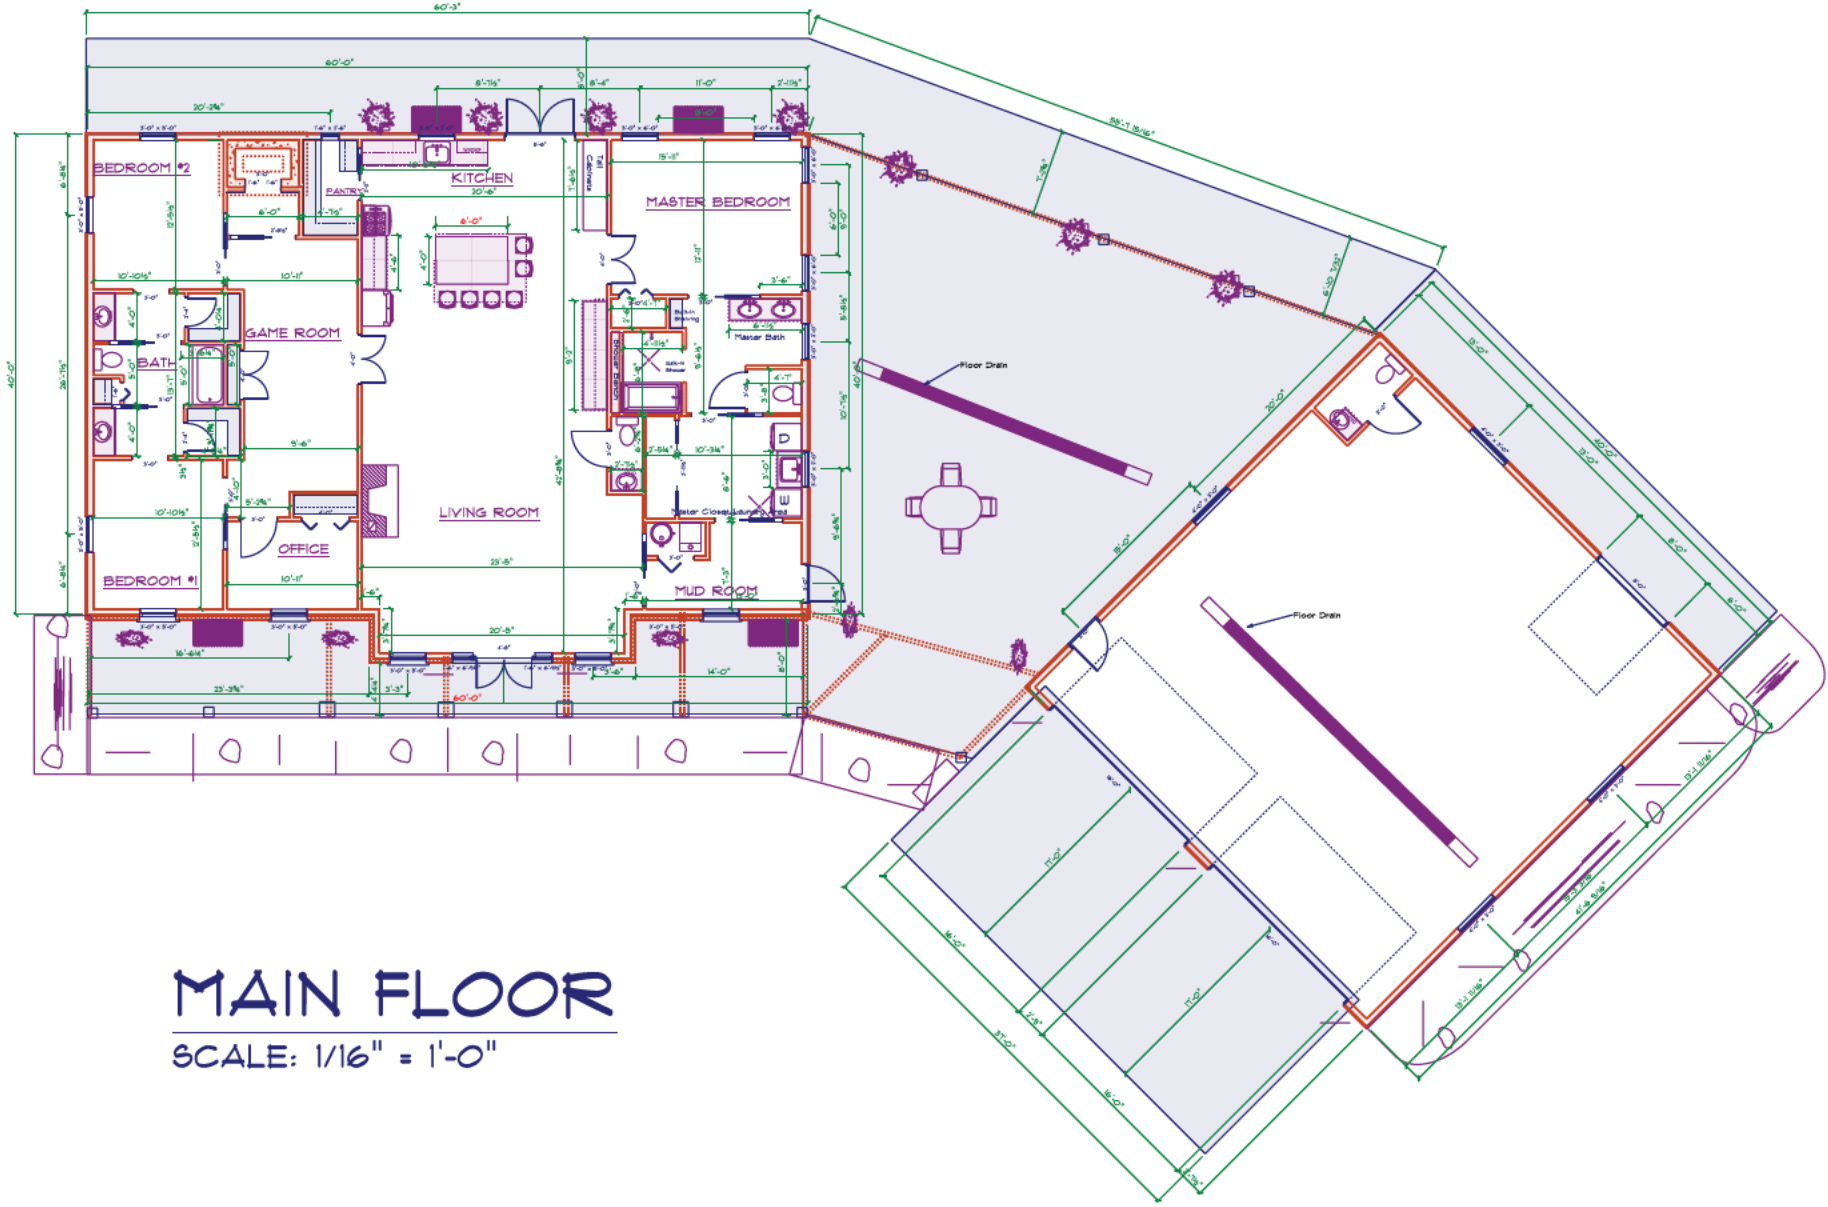

**MAIN FLOOR**  
SCALE: 1/16" = 1'-0"


SECTION LETTER: **A**  
PAGE NUMBERS: **11**

PHONE:  
FAX:  
MOBILE:

**GP Home Designs**  
2664 248th Street  
Oskaloosa  
Iowa  
52577  
PHONE: (641) 660-7256  
greg@GPhomedesigns

DRAWN BY: Greg Patton  
SCALE: 1/16" = 1'-0"  
DATE: Thursday, April 14, 2022

**GP Home Designs**  
Oskaloosa, IA

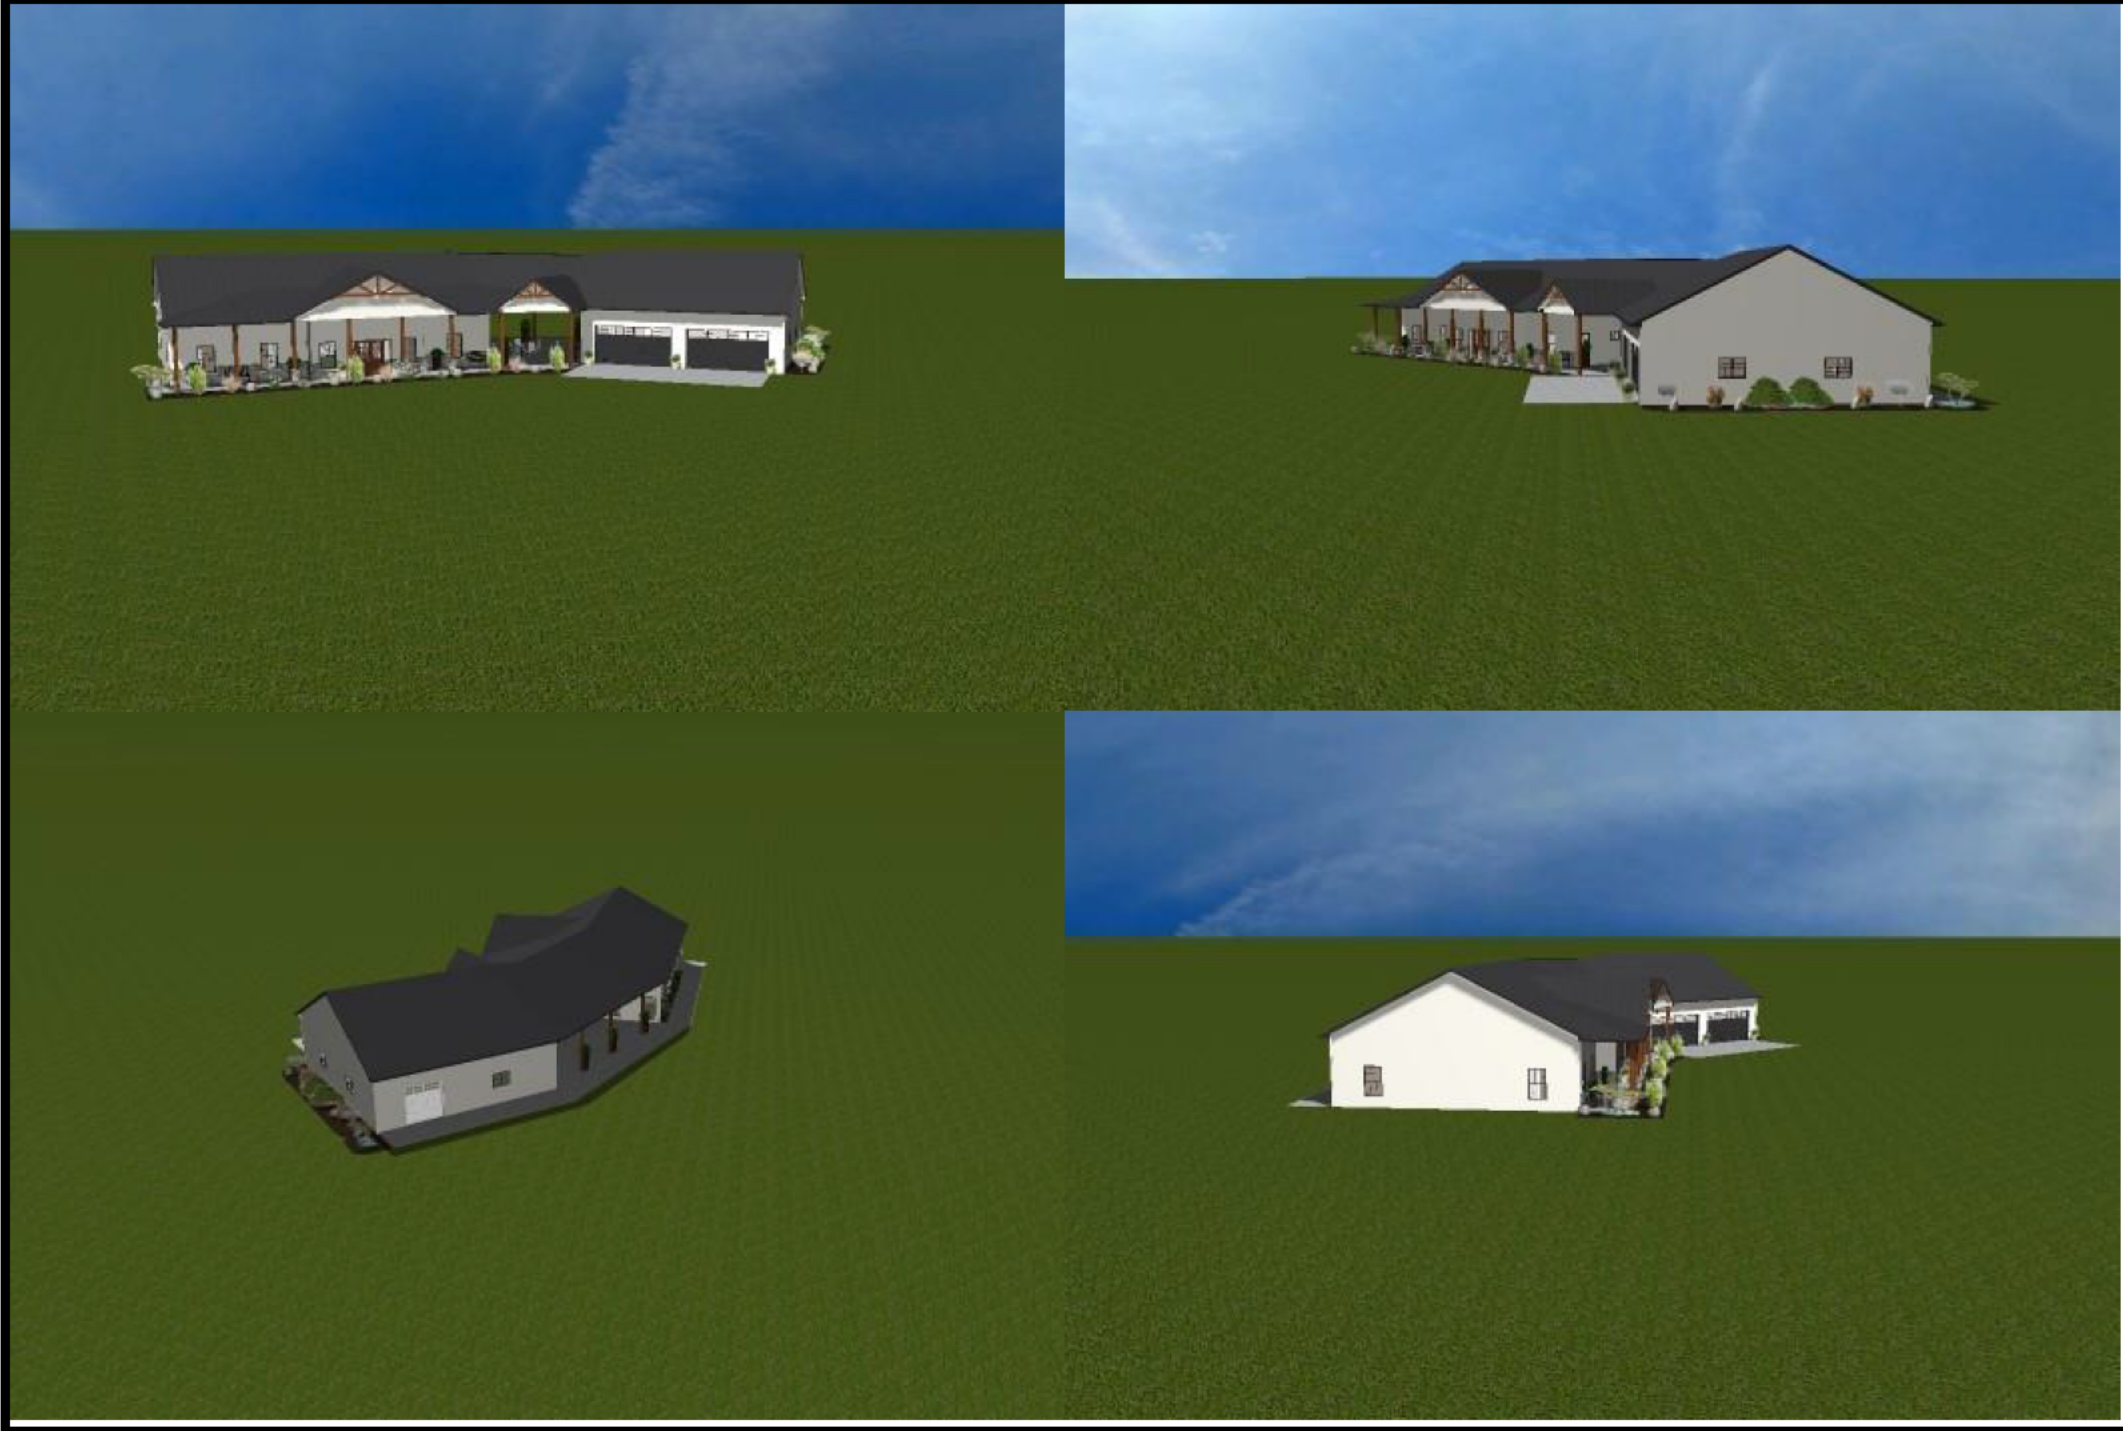


**GP Home Designs**

2664 248th Street  
Oskaloosa

Iowa  
52577

PHONE: (641) 660-7256

greg@GPhomedesigns

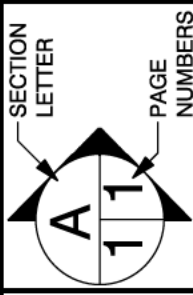

SECTION LETTER: **A**  
PAGE NUMBERS: **111**  
PAGE: **4/6**  
3D Views




PHONE:  
FAX:  
MOBILE:

DRAWN BY: Greg Patton

SCALE: As Noted

DATE: Thursday, April 14, 2022

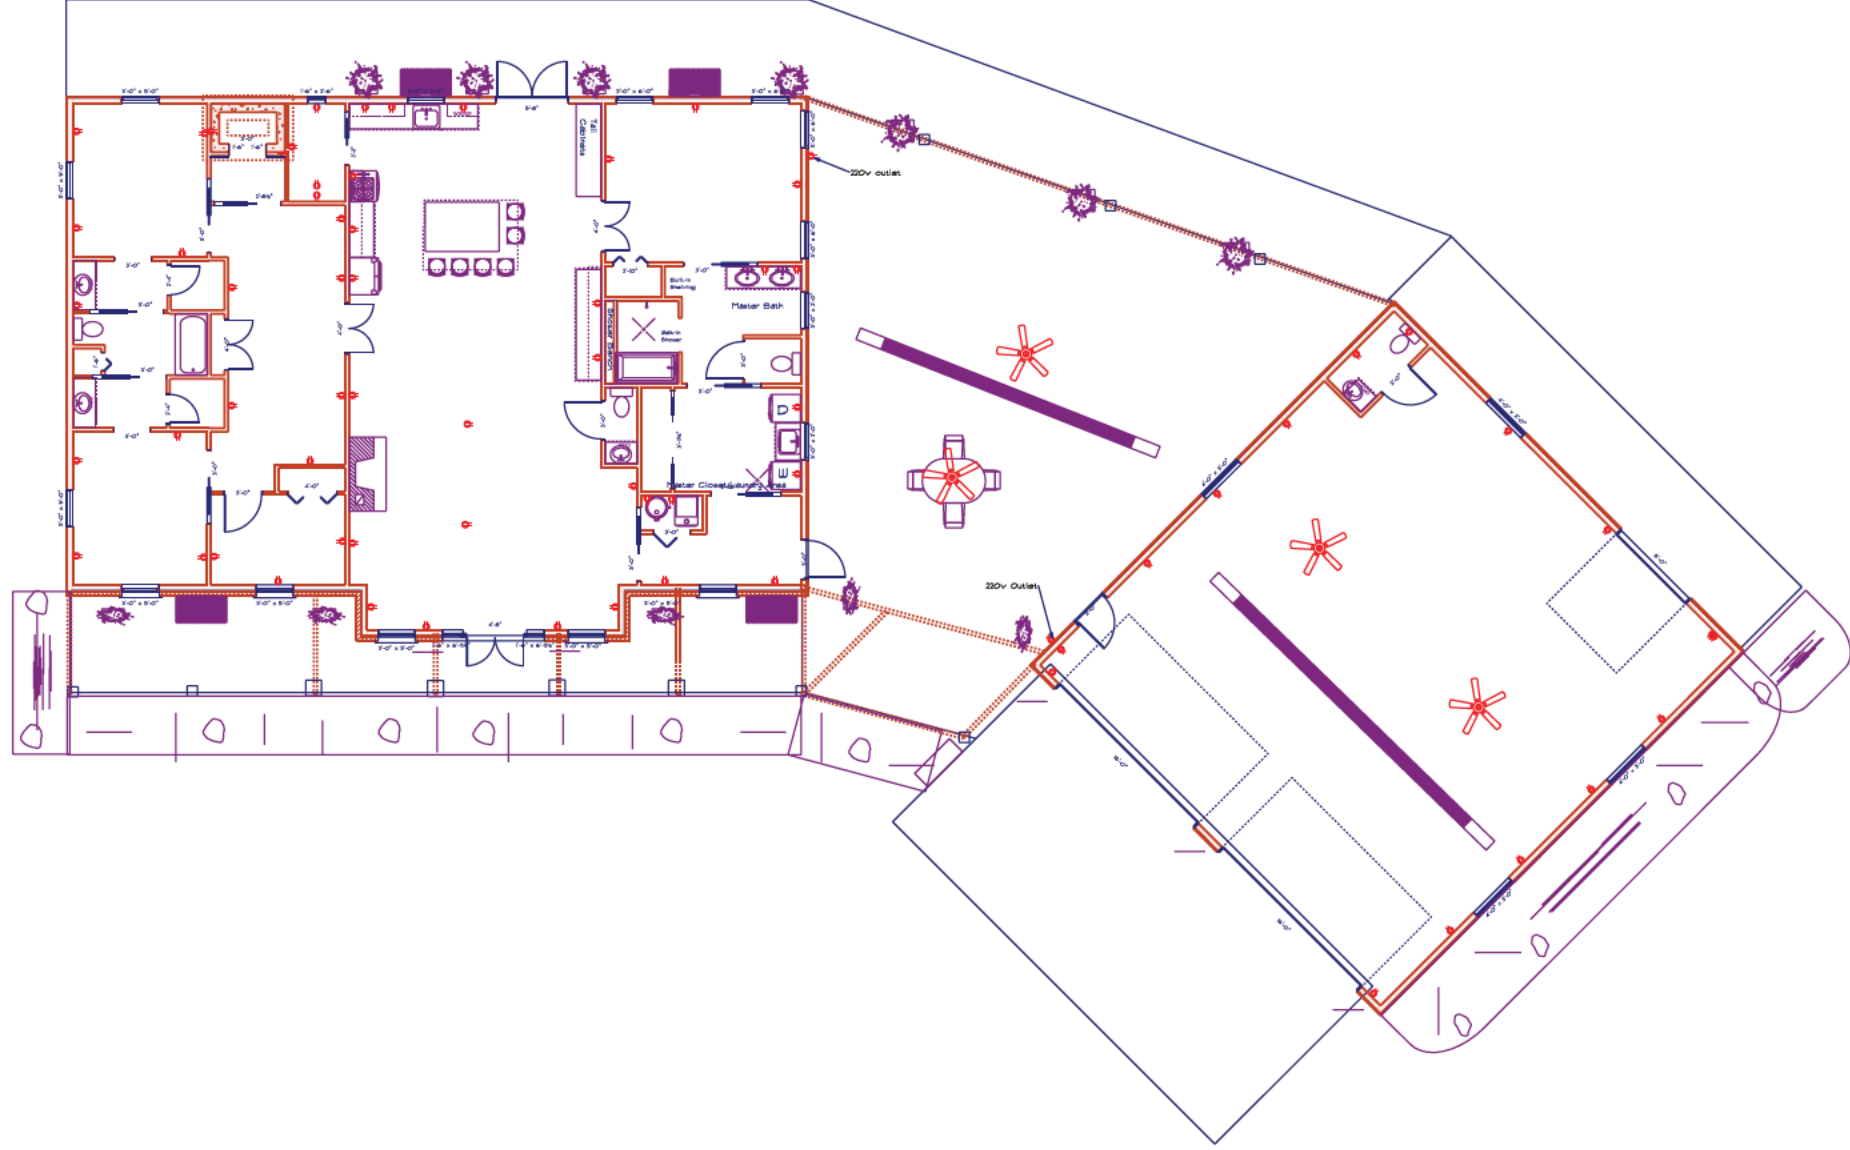

# MAIN FLOOR - ELECTRICAL

SCALE: 0.0641" = 1'-0"

## GP Home Designs

2664 248th Street  
 Oskaloosa  
 Iowa  
 52577  
 PHONE: (641) 660-7256  
 greg@GPhomedesigns



PHONE:  
 FAX:  
 MOBILE:

DRAWN BY: Greg Patton

SCALE: 0.0641" = 1'-0"

DATE: Thursday, April 14, 2022

SECTION LETTER  
**A**  
 PAGE NUMBERS  
**1/1**

PAGE: **5/6**  
 Electrical Layout

All Trusses are Pre-Engineered to each building  
Trusses come with 30lb Ground Snow Loading  
on Top Chord.  
Optional Bottom chord  
rating available to meet your  
specific building needs.

Flush Framing  
Girts are 2' on Center  
22" 2x6 applied to each side of wall column  
Wall girts fits flush to the  
inside and outside of building  
Each Girt is cut to wall column spacing

Metals Panels are 29 gauge SMP  
Galvalume AZ250  
class 4  
Lifetime Paint Warranty  
30yrs Fade Warranty  
20yrs Perforation Warranty  
Substrate 1.60 mil

Foundation Columns  
#1 Grade Southern Yellow pine  
3=Ply Glue Laminated  
48" Deep  
CCA .40 Treated  
50 year Warranty


**GP Home Designs**

2664 248th Street  
Oskaloosa

Iowa  
52577

PHONE: (641) 660-7256

greg@GPhomedesigns

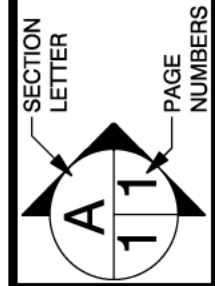

PAGE: **6/6**  
Materials

PHONE:  
FAX:  
MOBILE:

DRAWN BY: Greg Patton  
SCALE: As Noted  
DATE: Thursday, April 14, 2022